



**2 FIRST FLOOR PLAN REMOVALS**  
 A3 Scale: 1/8" = 1'-0"

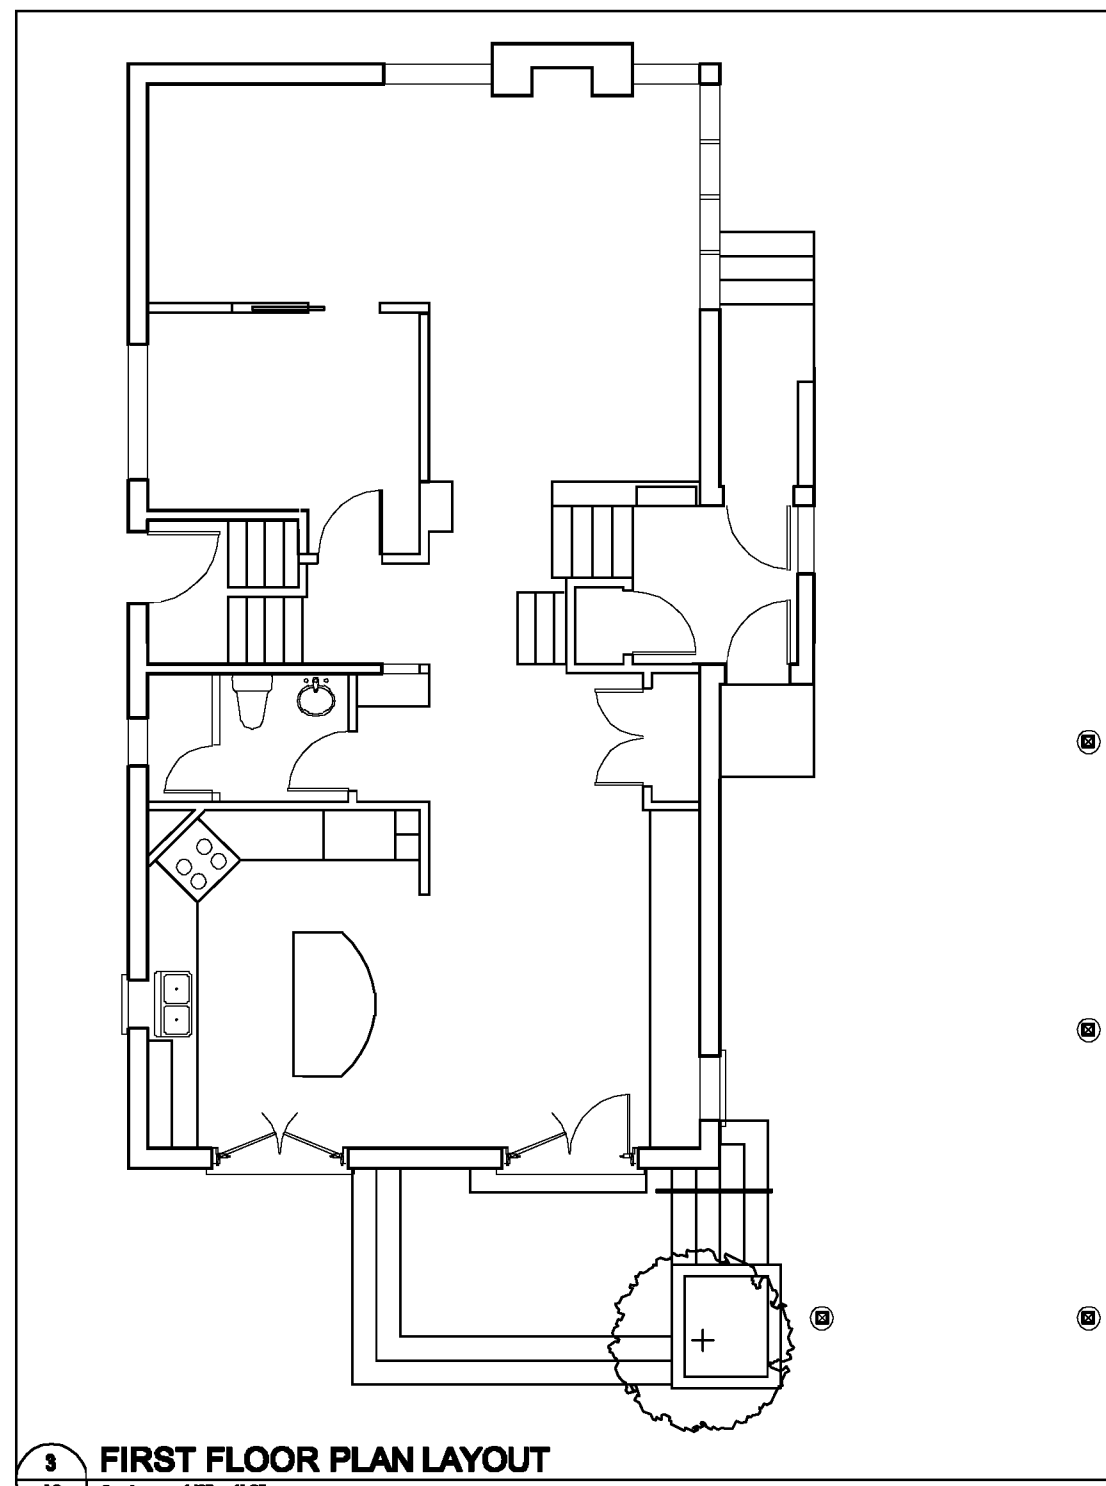

**3 FIRST FLOOR PLAN LAYOUT**  
 A3 Scale: 1/8" = 1'-0"

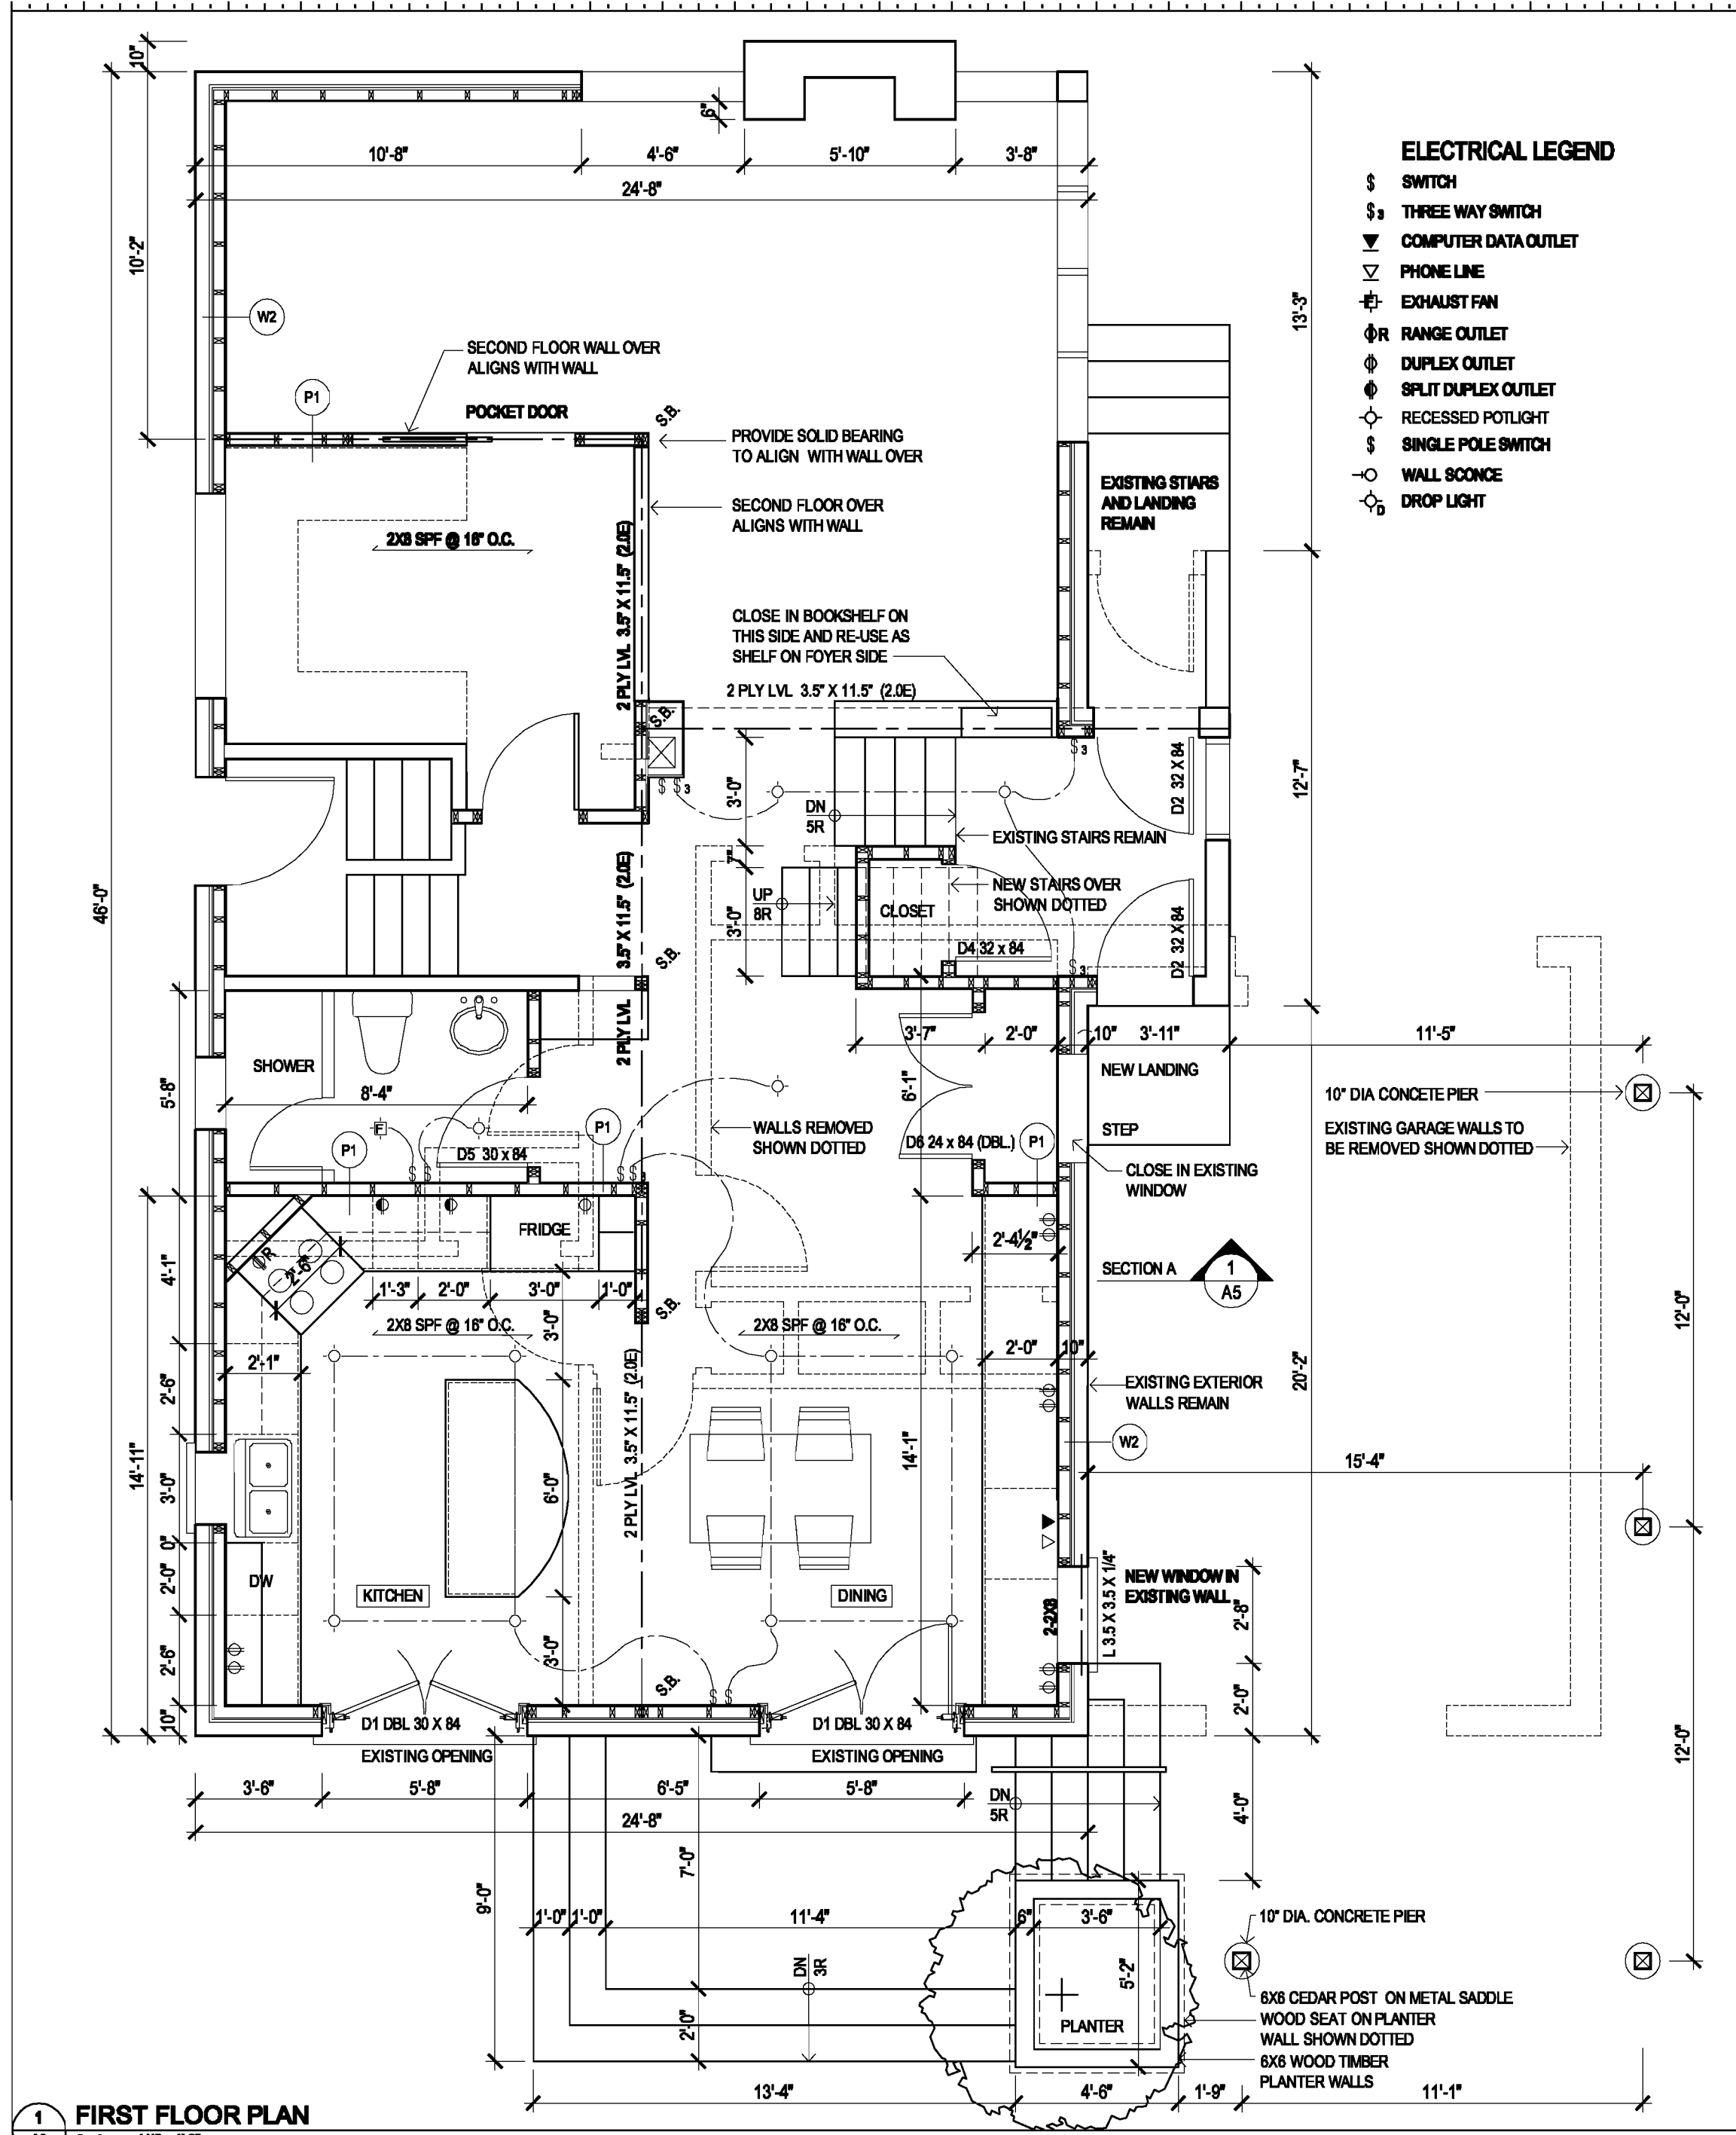

**1 FIRST FLOOR PLAN**  
 A3 Scale: 1/4" = 1'-0"

- ELECTRICAL LEGEND**
- ⊞ SWITCH
  - ⊞ THREE WAY SWITCH
  - ⊞ COMPUTER DATA OUTLET
  - ⊞ PHONE LINE
  - ⊞ EXHAUST FAN
  - ⊞ RANGE OUTLET
  - ⊞ DUPLEX OUTLET
  - ⊞ SPLIT DUPLEX OUTLET
  - ⊞ RECESSED POTLIGHT
  - ⊞ SINGLE POLE SWITCH
  - ⊞ WALL SCONCE
  - ⊞ DROP LIGHT

**jba John Boone ARCHITECT**  
 185 Carlton Street, Toronto, Ontario, M5A 2K7  
 Tel: 416 469 3284 Email: jboone@jboinreed.com  
 This drawing is the Property of John Boone Architect and may be used for this project only. Scale from drawings for reference only. Dimensions to be checked and verified by the contractor on site.

**225 ISLAND ROAD**  
 Toronto, Ontario

**FIRST FLOOR PLAN**  
 DRAWING SCALE 1/4" = 1'-0"  
 PROJECT DATE MAR 2007  
 PROJECT NUMBER 07A04  
 DRAWN BY JB

PLOT DATE: October 08, 2007

No.	DATE	SUBMITTED FOR CLIENT REVIEW	DESCRIPTION

**A3**